


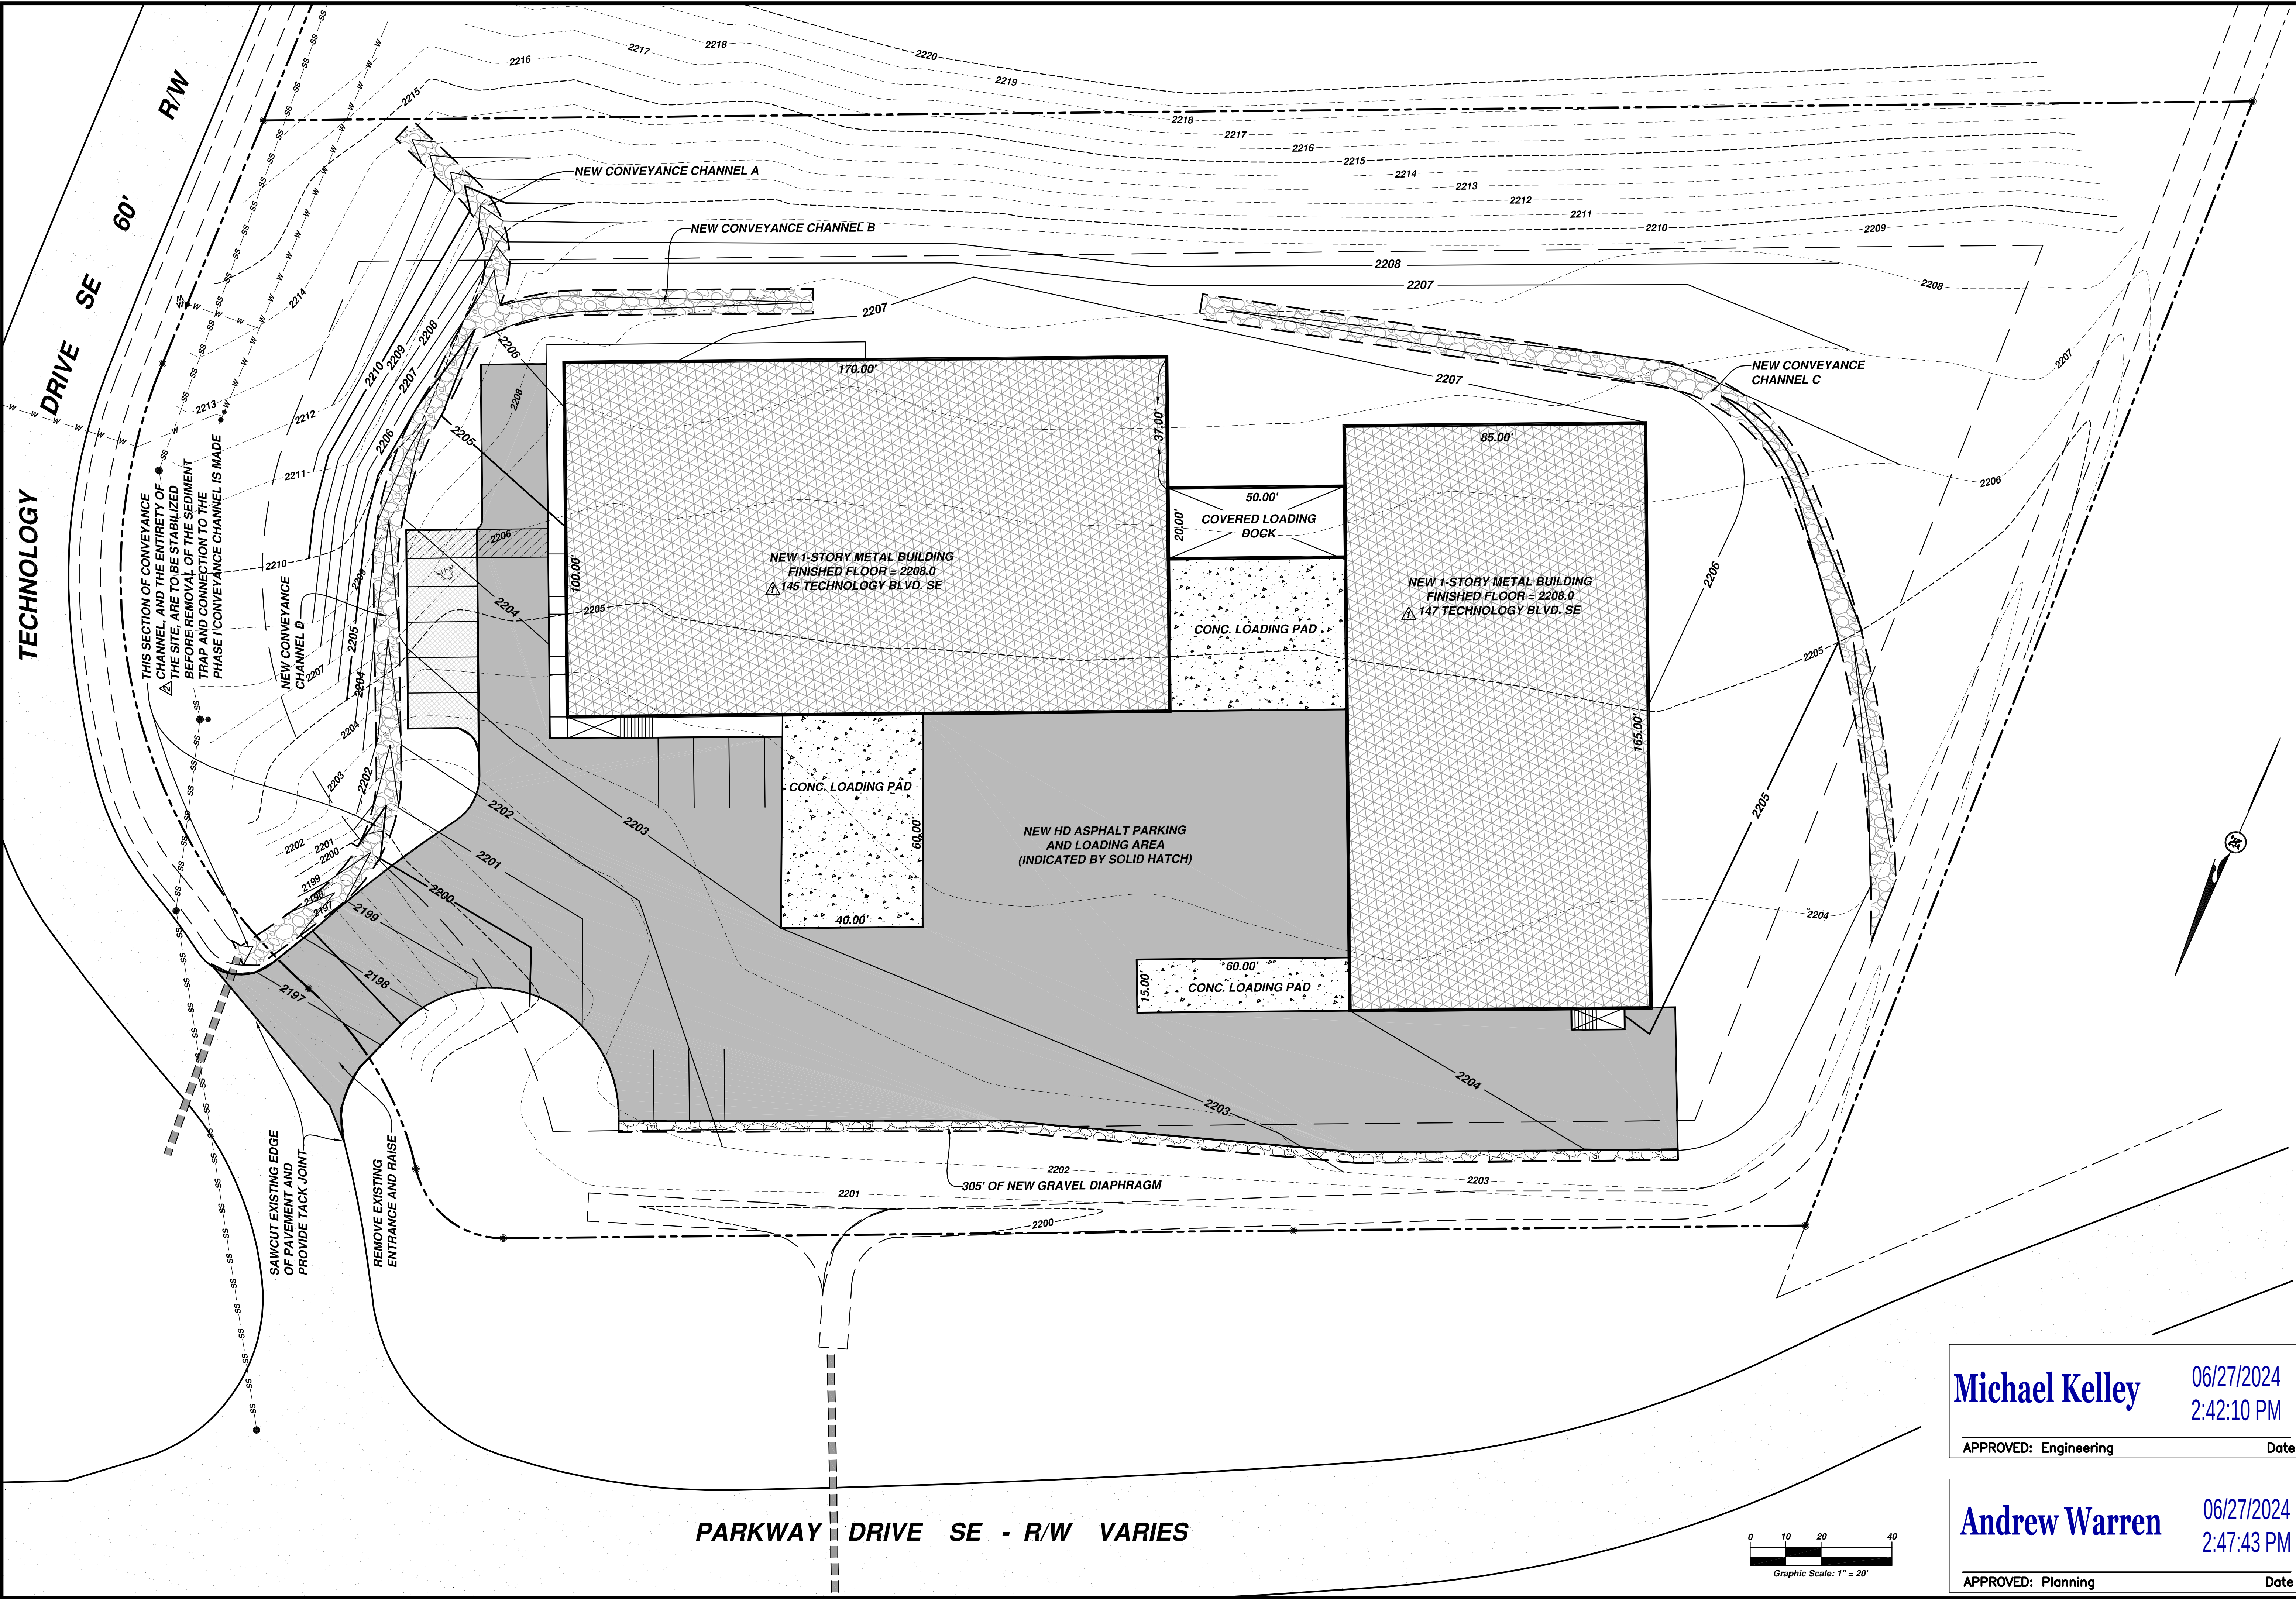

WALLER ENGINEERING
AND
LAND SURVEYING, INC.
PO BOX 44 Collinsville, Virginia 24078
Phone: 1-276-647-3506 - chwaller@vt.edu

ALACRAN

NEW METAL WAREHOUSE
FOR ALACRAN, INC.
145 AND 147 TECHNOLOGY BLVD., SE
TOWN OF CHRISTIANSBURG, VIRGINIA

REVISION		BY
DATE	REVISION	BY
6-7-24	PER TOWN COMMENTS	CHW
6-19-24	PER TOWN COMMENTS	CHW
FINAL GRADING PLAN		

CHRISTOPHER H. WALLER
Lic. No. 45226
June 26, 2024
PROFESSIONAL ENGINEER

DATE: September 18, 2023
SCALE: AS NOTED
DRAWN BY: CHW
SHEET NO.: 7 OF 12

Michael Kelley
APPROVED: Engineering
Date

06/27/2024
2:42:10 PM

Andrew Warren
APPROVED: Planning
Date

06/27/2024
2:47:43 PM