


THIS SHEET IS INTENDED TO BE REPRODUCED AT 24"X36". REPRODUCTION OF THIS SHEET AT A DIFFERENT SIZE THAN INTENDED SHALL VOID THE SCALE SHOWN ON THE SHEET.

J:\14_2025_24x36\14_2025_24x36\Operations Center Plans.dwg

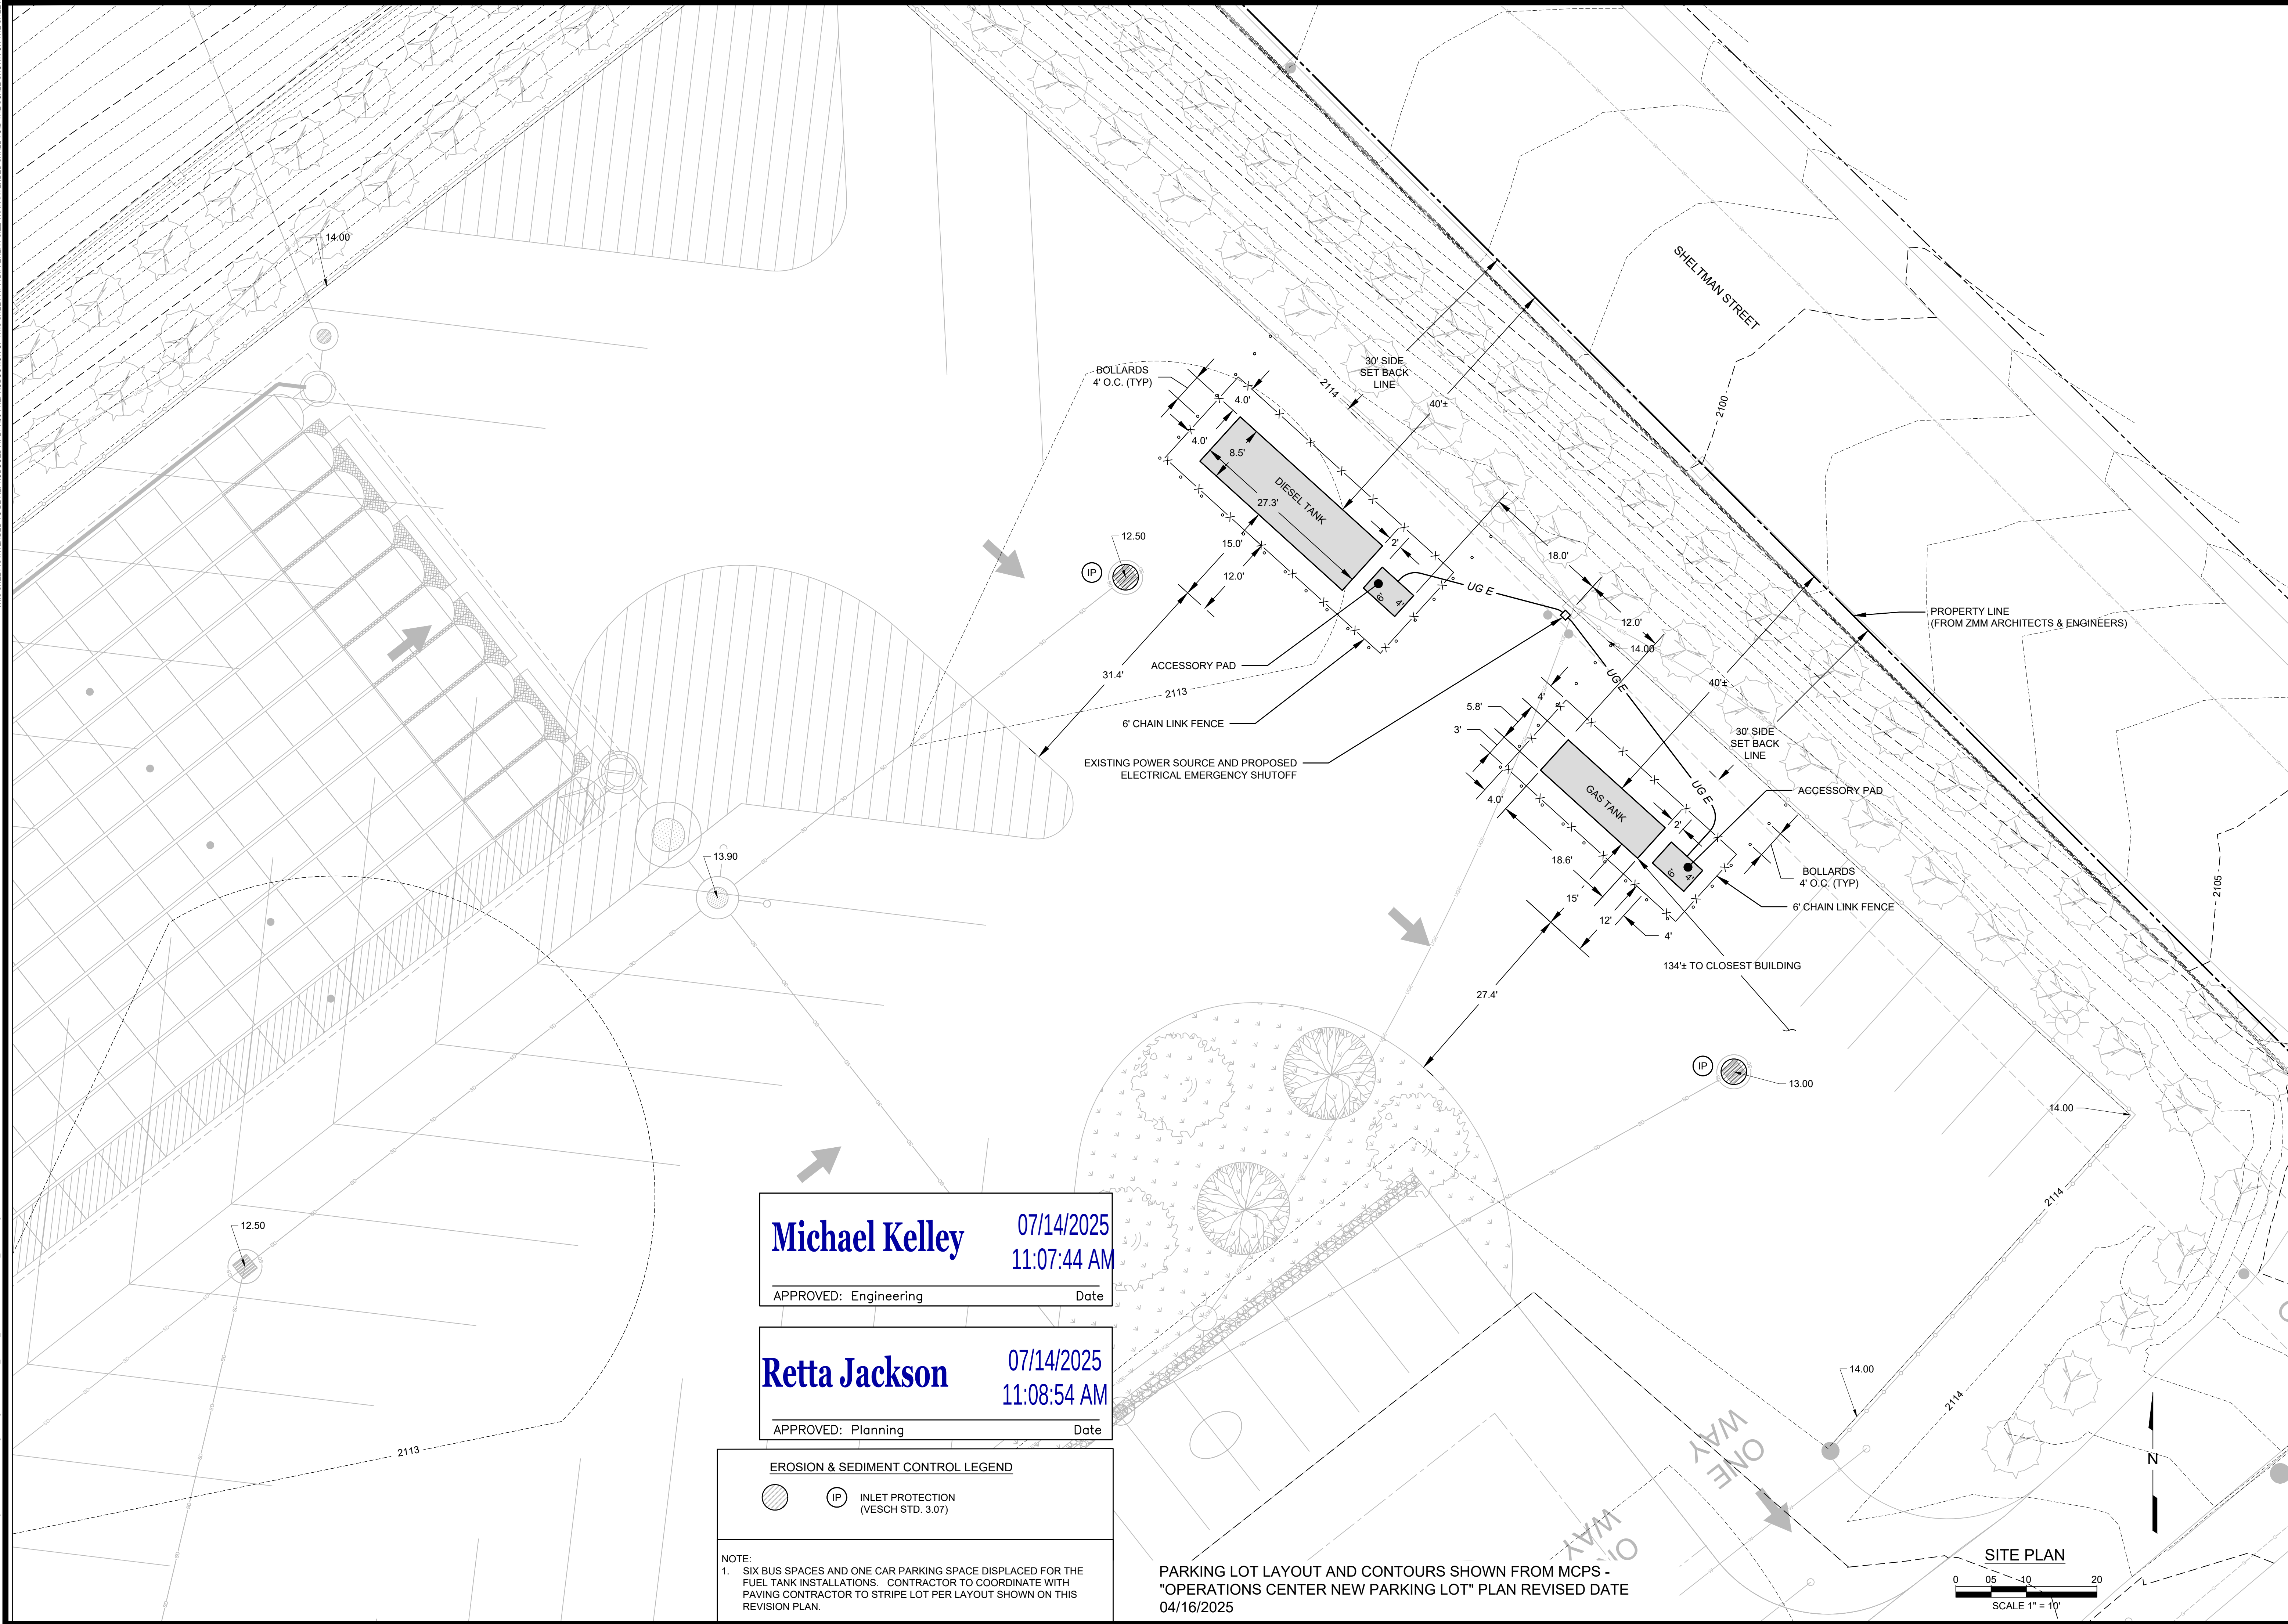

Michael Kelley

07/14/2025
11:07:44 AM

APPROVED: Engineering

Date

 
Retta Jackson

07/14/2025
11:08:54 AM

APPROVED: Planning

Date

EROSION & SEDIMENT CONTROL LEGEND



INLET PROTECTION
(VESCH STD. 3.07)

NOTE:

- SIX BUS SPACES AND ONE CAR PARKING SPACE DISPLACED FOR THE FUEL TANK INSTALLATIONS. CONTRACTOR TO COORDINATE WITH PAVING CONTRACTOR TO STRIPE LOT PER LAYOUT SHOWN ON THIS REVISION PLAN.

PARKING LOT LAYOUT AND CONTOURS SHOWN FROM MCPS -
"OPERATIONS CENTER NEW PARKING LOT" PLAN REVISED DATE
04/16/2025


SITE PLAN

0 05 10 20
SCALE 1" = 10'

FUEL TANK INSTALLATION PLAN

MCPS OPERATIONS CENTER
208 COLLEGE ST. NW
CHRISTIANSBURG, VA

PROJECT NO. 20242389
LAT. 37.129467
LONG. -80.414461
DATE: 25 JUN 2025
DRAWN BY: BEC
CHECKED BY: MTC

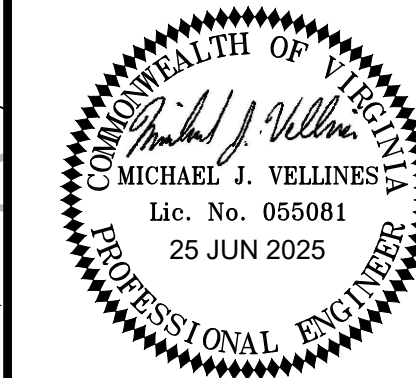

SITE LAYOUT
AND E&SC PLAN

HURT & PROFFITT

SHEET NO.
C200

REV.

HURT & PROFFITT

INSPIRED / RESPONSIVE / TRUSTED



540.552.5592
1861 PRATT DR. STE 1100
BLACKSBURG, VA 24060
ENGINEERING • SURVEYING • LAND DEVELOPMENT • ENVIRONMENTAL
GEOTECHNICAL • CONSTRUCTION TESTING & INSPECTION • CULTURAL RESOURCES